


SHEET DIRECTORY

INTERSTATE HIGHWAY 37  
(R.O.W. VARIES)

MB-ES1.1  
MB-ES1.0

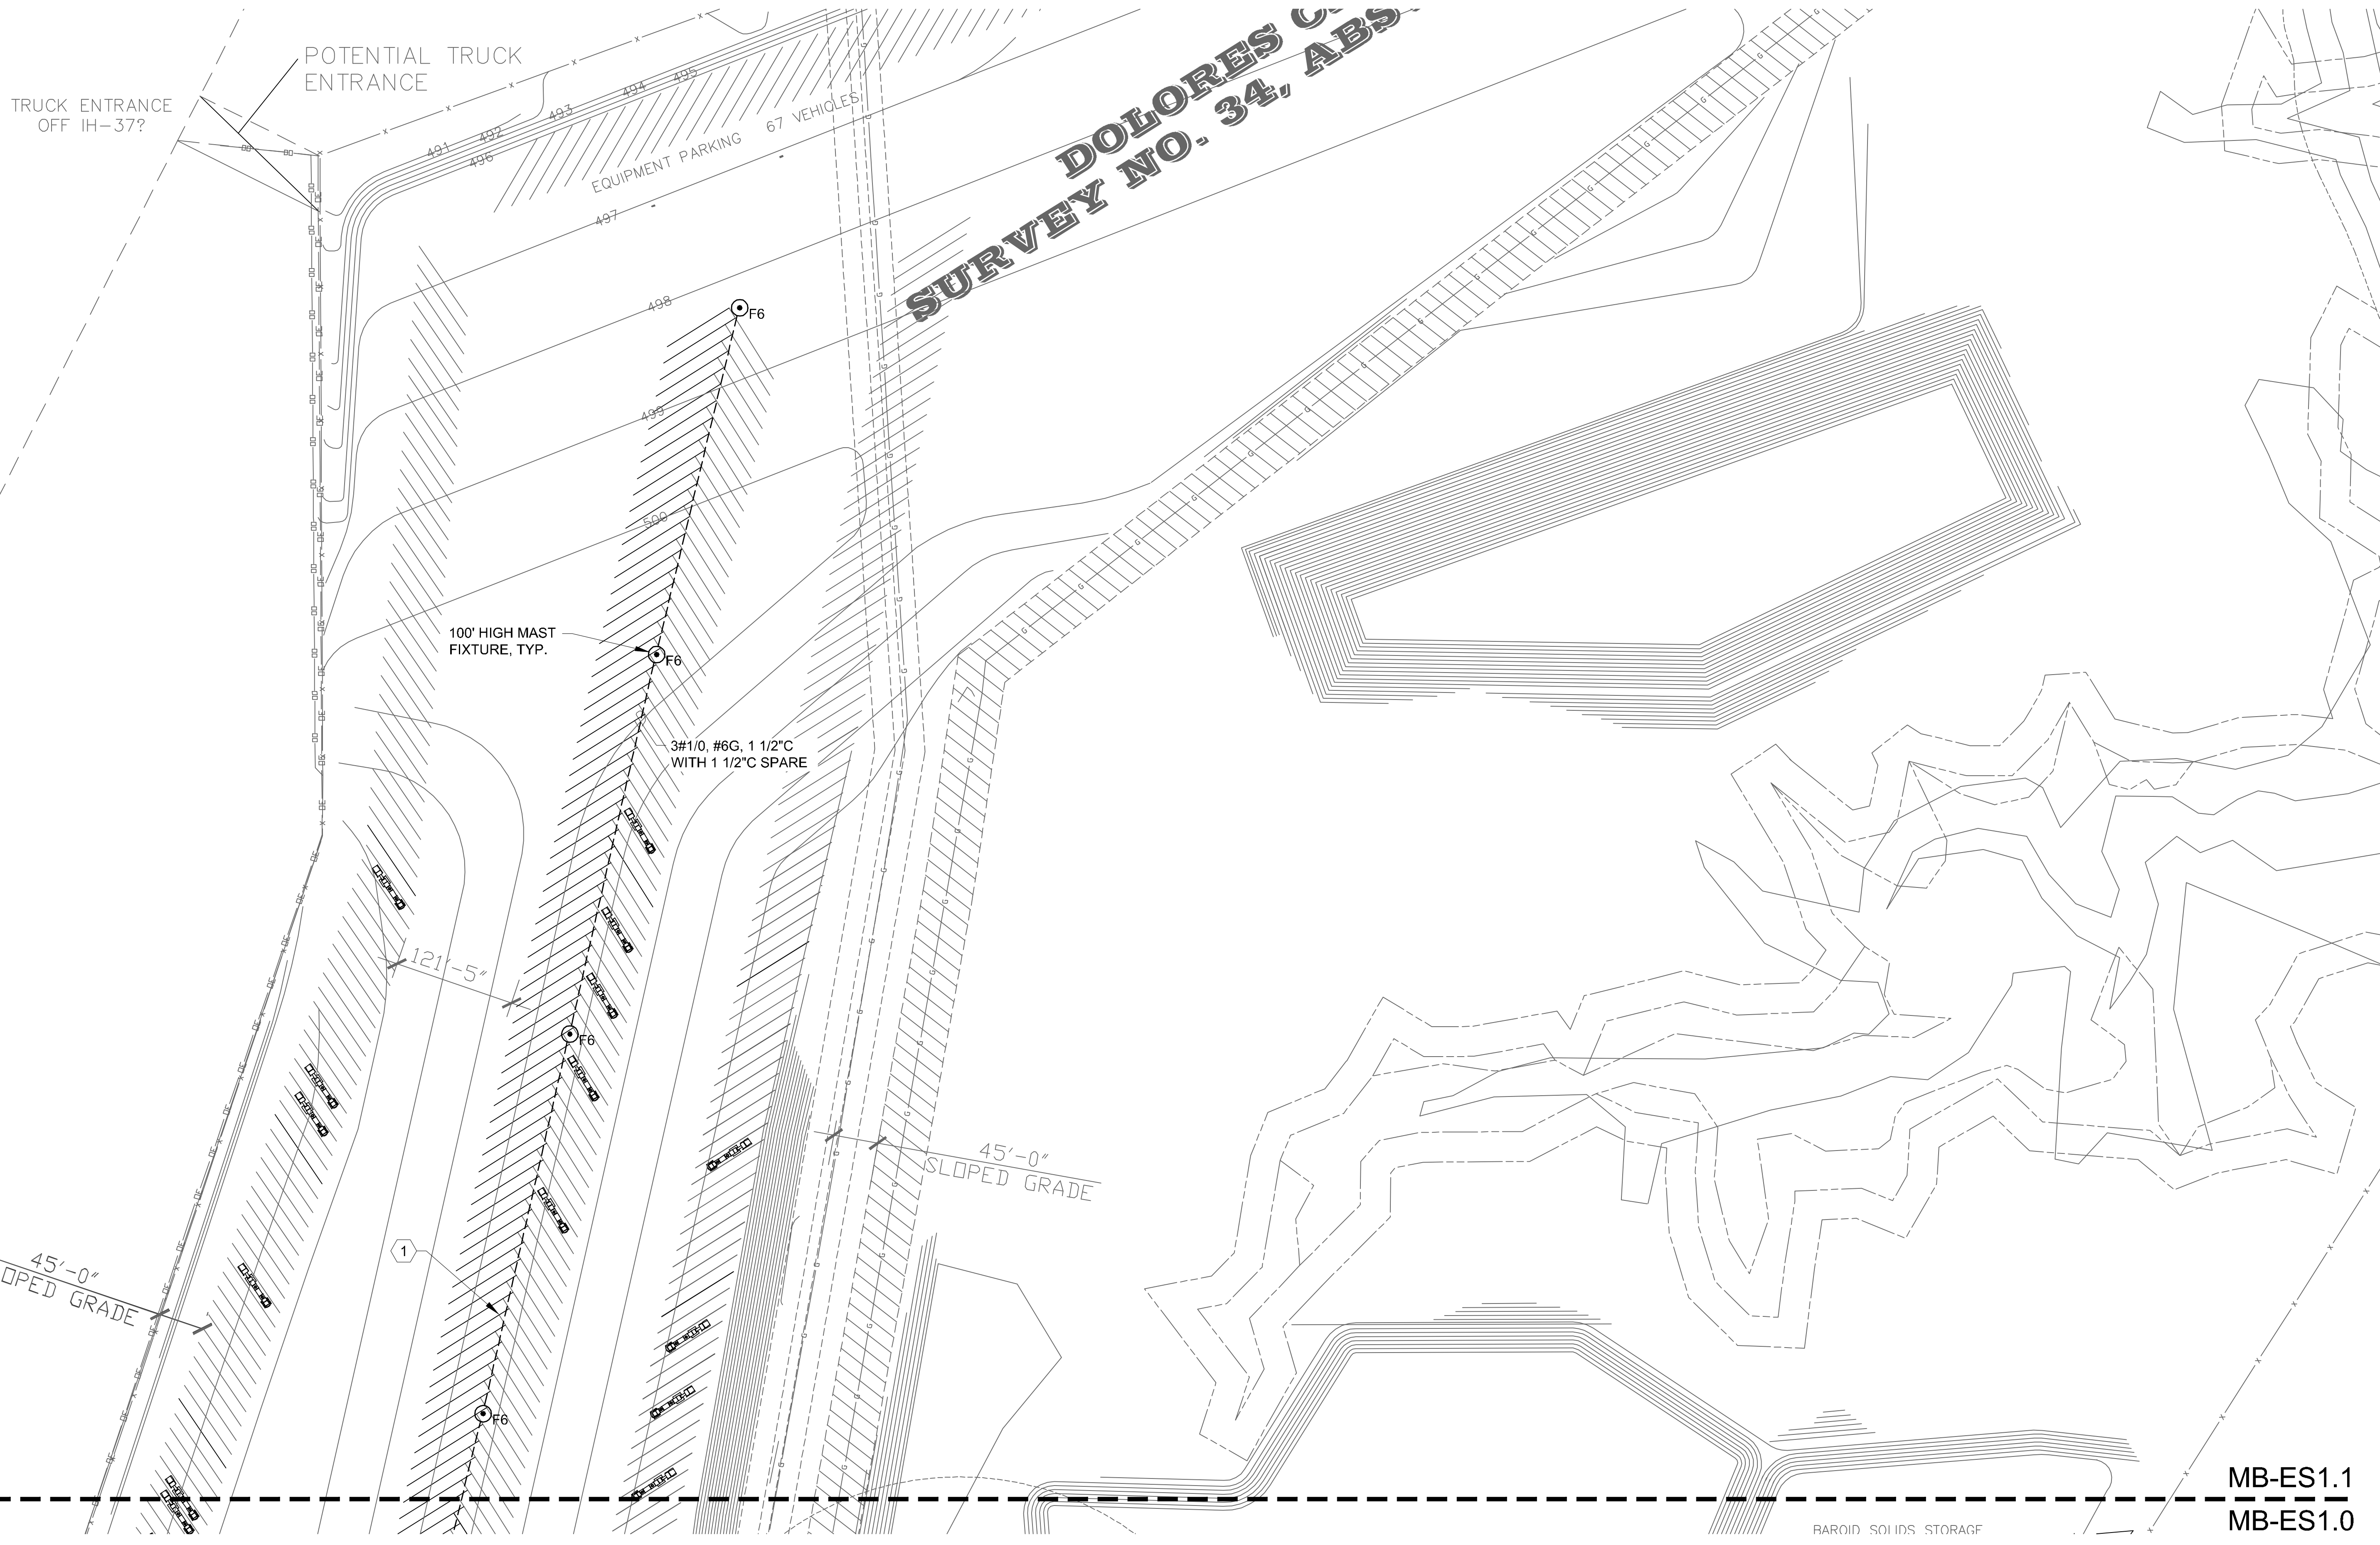

**1** ELECTRICAL SITE PLAN  
MB-ES1.1 SCALE: 1" = 80'-0"


GENERAL NOTES:	KEY NOTES:
<ol style="list-style-type: none"> <li>ANY SITE LIGHTING NOT INSTALLED IN IMMEDIATELY MUST BE PROVIDED WITH CONDUITS &amp; PULL STRINGS.</li> <li>ALL SPARE CONDUITS PROVIDED WITH PULL STRINGS.</li> </ol>	<ol style="list-style-type: none"> <li>PROVIDE 24" x 36" x 24"D PULL BOX WITH TRAFFIC RATED LID, ADJACENT TO TEMPORARY MAINTENANCE BUILDING LOCATION, WHEN DETERMINED, MAKE TEMPORARY LIGHTING CIRCUIT POWER FEED TO THIS PULL BOX.</li> </ol>

THE INFORMATION CONTAINED HEREIN SHALL BE CONSIDERED THE SOLE PROPERTY OF HALLIBURTON COMPANY AND THE RECIPIENT THEREOF AGREES NOT TO DISCLOSE SAID INFORMATION TO PARTIES OUTSIDE THE RECIPIENT'S ORGANIZATION AND NOT TO REPRODUCE, COPIY, OR TRANSMIT IN ANY MANNER WITHOUT THE WRITTEN PERMISSION OF HALLIBURTON REAL ESTATE SERVICES.

CHG	DESCRIPTION	DATE	BY

PRELIMINARY :  
NOT FOR  
REGULATORY  
APPROVAL,  
PERMITTING, OR  
CONSTRUCTION

TBPE Reg #F351  
2821 WEST 7TH STREET  
SUITE 400  
FORT WORTH, TEXAS 76107

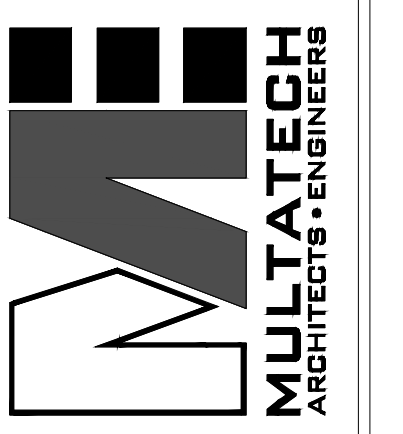

**HALLIBURTON**  
HES FIELD CAMP SAN ANTONIO  
ELECTRICAL  
SITE PLAN  
SAN ANTONIO, TEXAS 78112  
MAINTENANCE BUILDING  
10.0.0005.01.001  
10.0.0005.01.001  
10.0.0005.01.001

HES FIELD CAMP SAN ANTONIO  
ELECTRICAL  
SITE PLAN  
SAN ANTONIO, TEXAS 78112  
MAINTENANCE BUILDING

DESIGNED	
DRAWN	
APPROVED	
H.S.E. CHK	
ISSUE DATE:	11/14/2011

MB-ESI.1  
SHEET OF -